



FLOOR PLAN
SCALE 1/8" = 1'-0"


NOTE: DIMENSIONS MARKED "U.C." SHALL BE UNDERCUT 1/4"

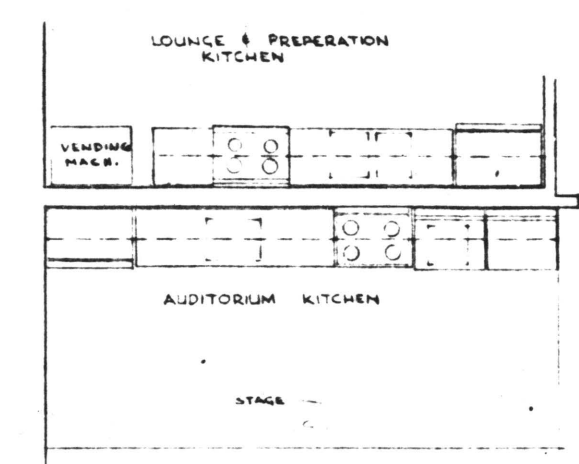


PLAN
SCALE 1/4" = 1'-0"

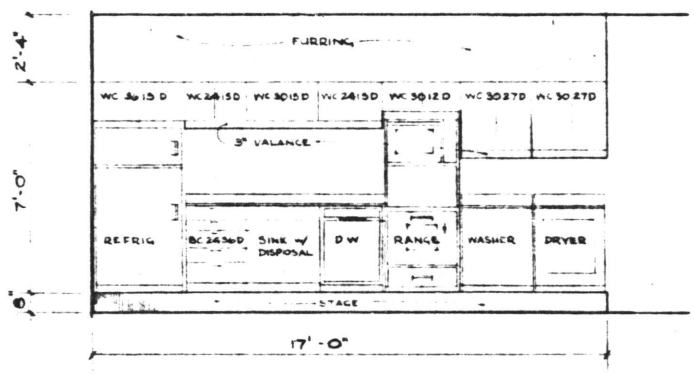

AUDITORIUM KITCHEN
SCALE 1/4" = 1'-0"

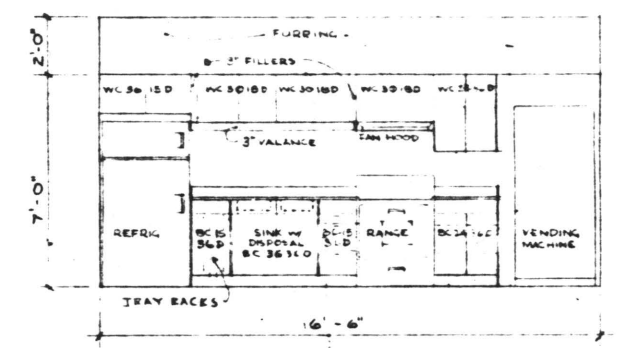

PREPARATION KITCHEN
SCALE 1/4" = 1'-0"

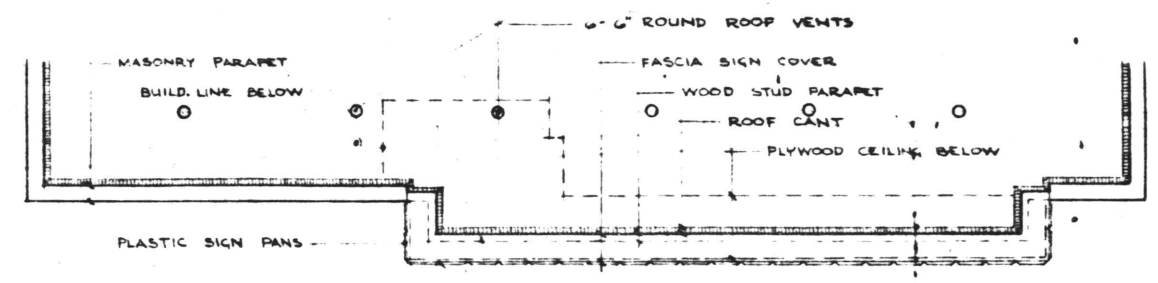

PARTIAL ROOF PLAN
SCALE 1/8" = 1'-0"

ALABAMA POWER COMPANY	
JOB CLANTON DISTRICT OFFICE	
DETAIL FLOOR PLAN & DETAILS	
SCALE AS NOTED -	B/M
DRAWN DARYL	CHECKED _____
APPROVED <i>D.B. Hart</i>	DATE 23 Nov 73
APPROVED _____	DATE 31 Oct 73
SHEET 2 OF 7 SHEETS	
SUPERSEDES _____	
C-194689	